


- wall type A

20mm render
100mm medium density block
50mm ventilated cavity
low E breather membrane
low E breather membrane
145mm SVK lite
145mm knauf frametherm 32
500 gauge visqueen
50mm knauf Omnitix insulation
15mm TE plasterboard
U-Value 0.17W/m²K
- wall type B

Ecoscape stucco composite cladding
50x50mm battens
50x50mm counter battens
low E breather membrane
low E breather membrane
145mm SVK lite
145mm knauf frametherm 32
500 gauge visqueen
75mm knauf Omnitix insulation
15mm TE plasterboard
U-Value 0.17W/m²K
- wall type C

20mm render
100mm medium density block
15mm cavity
100mm medium density block
50x23mm svk battens
50x23mm svk battens
Ecoscape stucco composite cladding
15mm TE plasterboard
- wall type D

20mm render
100mm medium density block
50mm ventilated cavity
low E breather membrane
low E breather membrane
145mm SVK lite
145mm knauf frametherm 32
500 gauge visqueen
15mm TE plasterboard

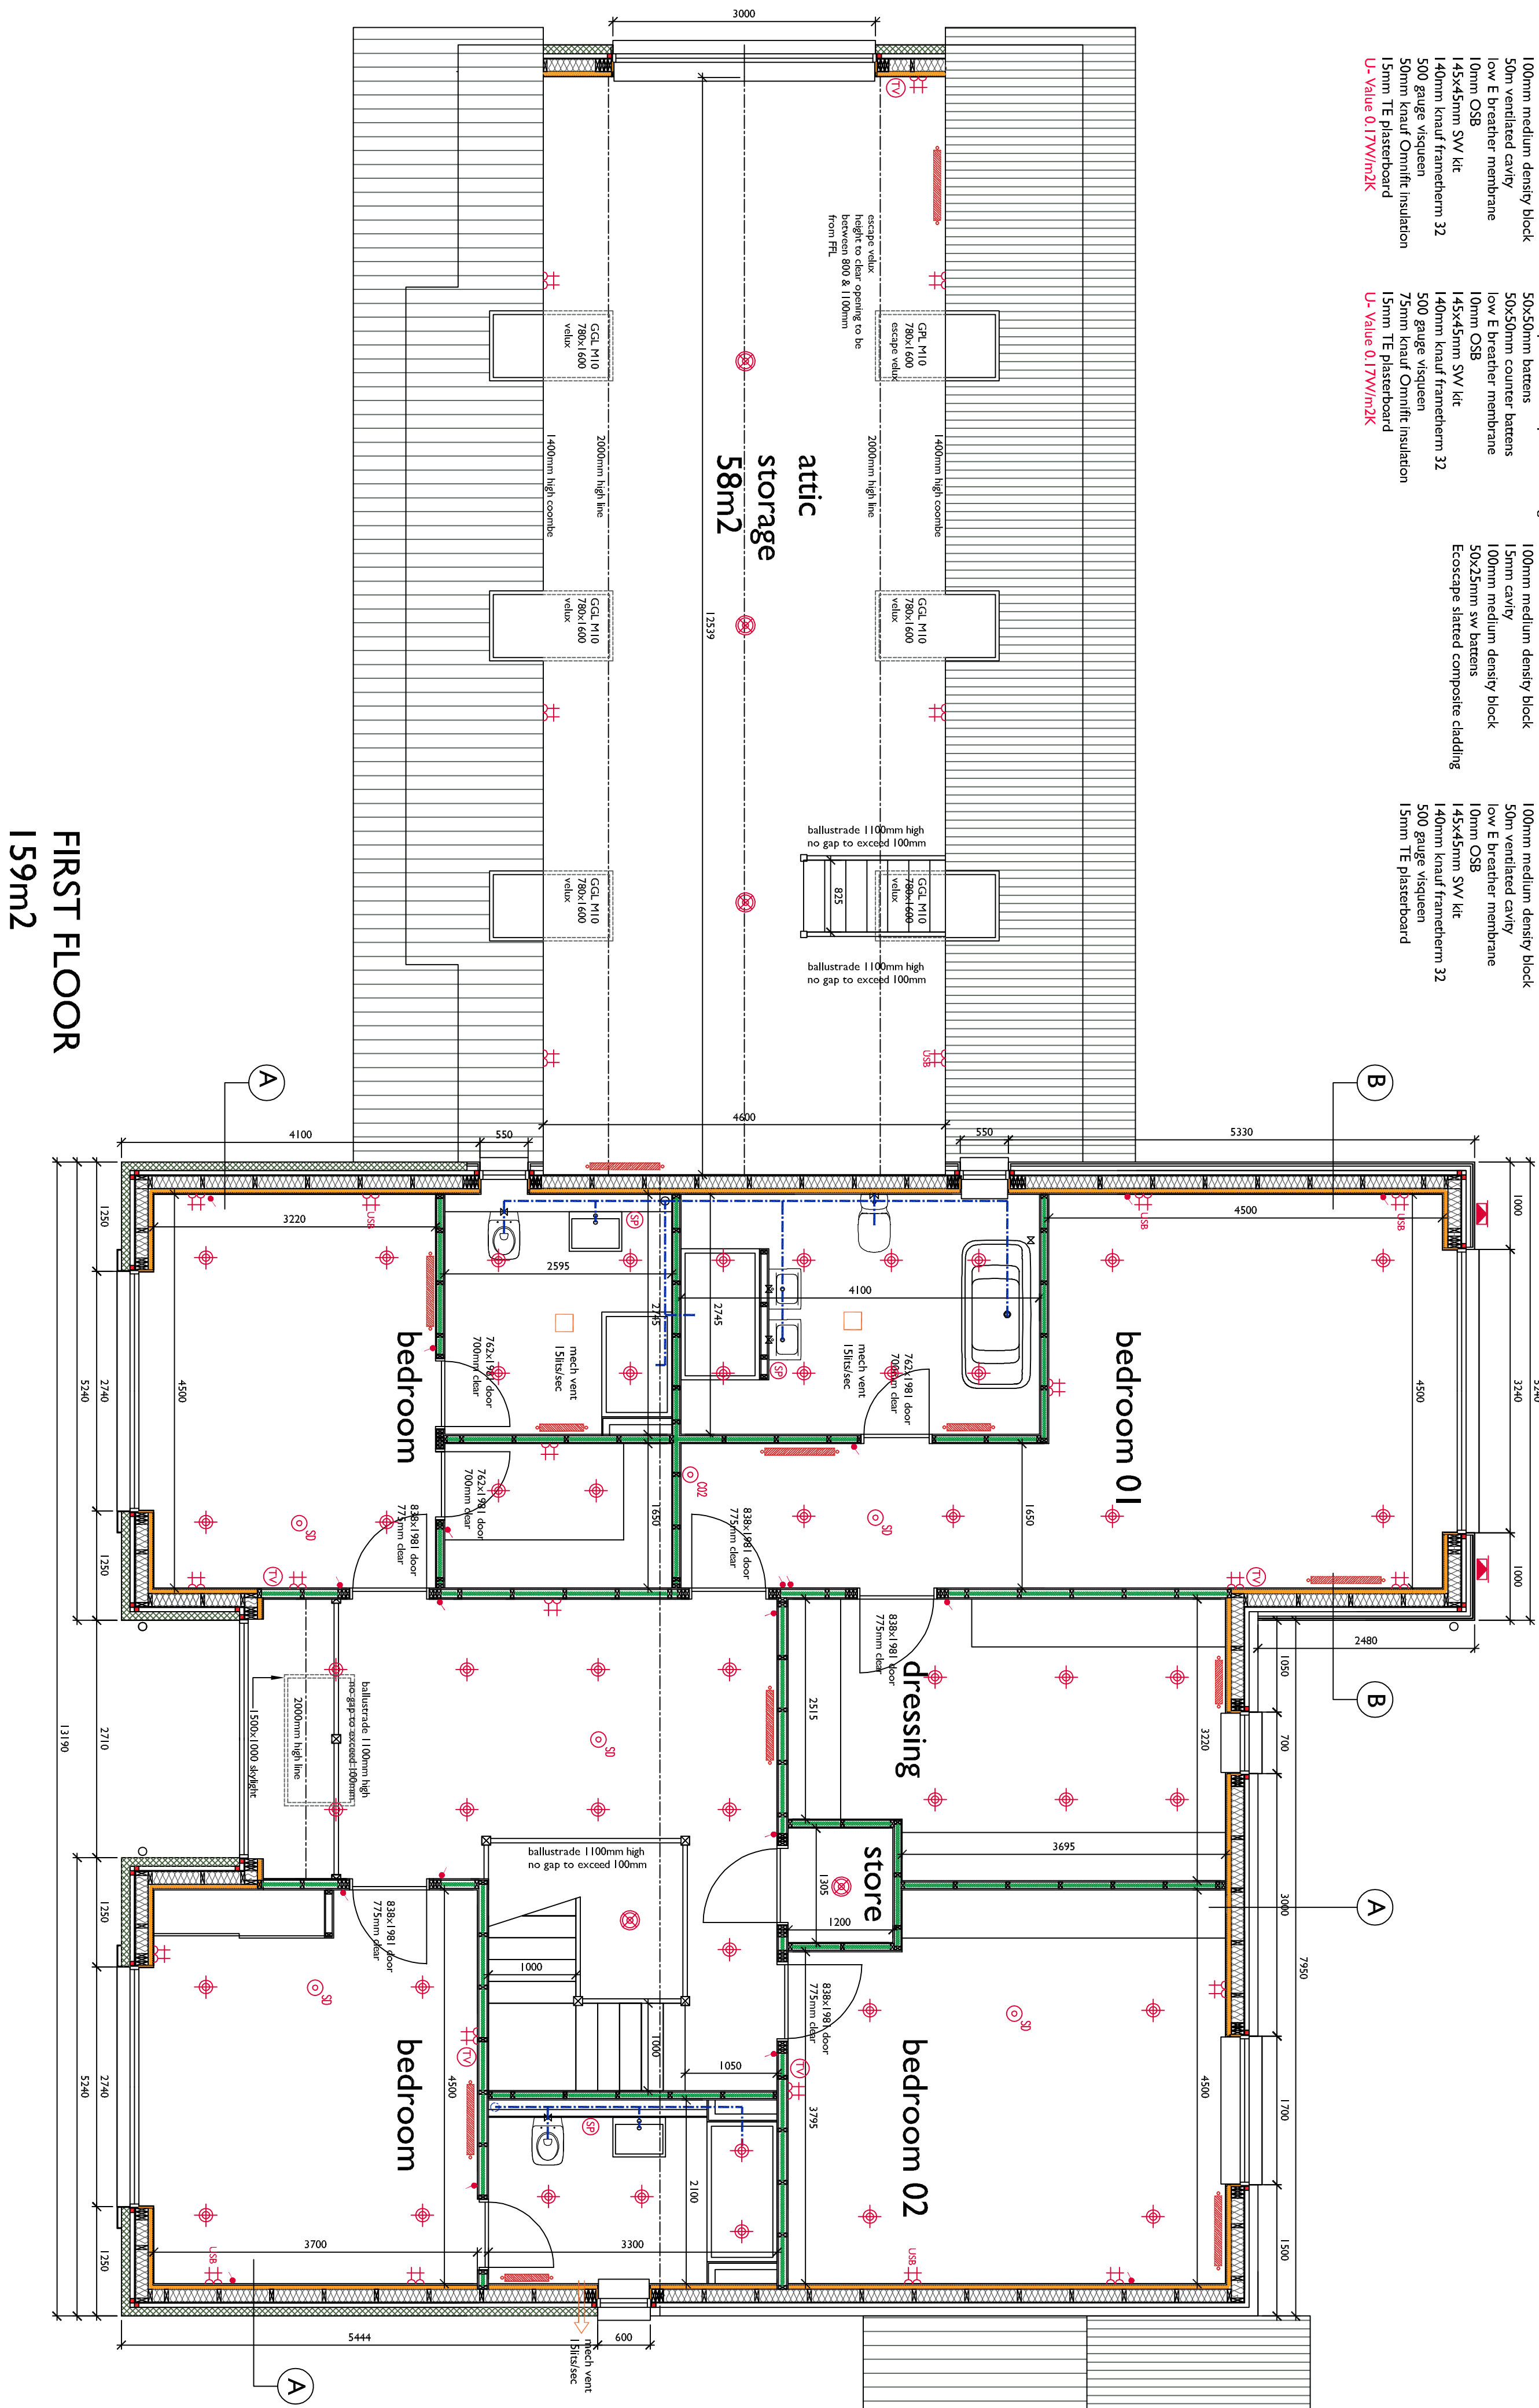

- ELECTRICAL LEGEND

LED

low voltage fire rated spot lights

Tungsten light fitting

WALL LIGHT - DUSK TILL DAWN PERS

ALSO INTERNALLY SWITCHED

Incoming telephone point

spur for kitchen appliances linked to dabbled

(exact position of sockets to be agreed)

13 Amp switched twin socket

Cooler Point (15 Amp)

Automatic Optical Smoke Detector/Alarm

Automatic Heat Detector

Carbon Dioxide Detector (wall mounted)

Carbon monoxide Detector

Light Switch

Distribution Board

Television Point

Car charger

Shower Point



Client: WILLIAM & CLARE GORDON
Address: GILTFOOT MANSION, CROSSFOOT, MILS SPY
Project: NEW DWELLING HOUSE

Drawing: FIRST FLOOR PLAN
Scale: 1:50 @ A1
Date: 24.11.11
Rev: 4